



SCHEMATIC DESIGN

Site Utilities

SARATOGA
ASSOCIATES

emphas!s


HLB
horton lees brogden lighting design

ip IP GROUP
CONSULTING ENGINEERS
548 Broadway No. 430
NEW YORK, NY 10012
212 982 3877 T
212 614 0752 F

WAI WEIDLINGER ASSOCIATES® INC
CONSULTING ENGINEERS


Michael Gotkin
Preservation & Planning Consultant
T. 212.316.4209 C. 646.244.4596

ND NORTHERN
DESIGNS
Irrigation Consultants & Designers

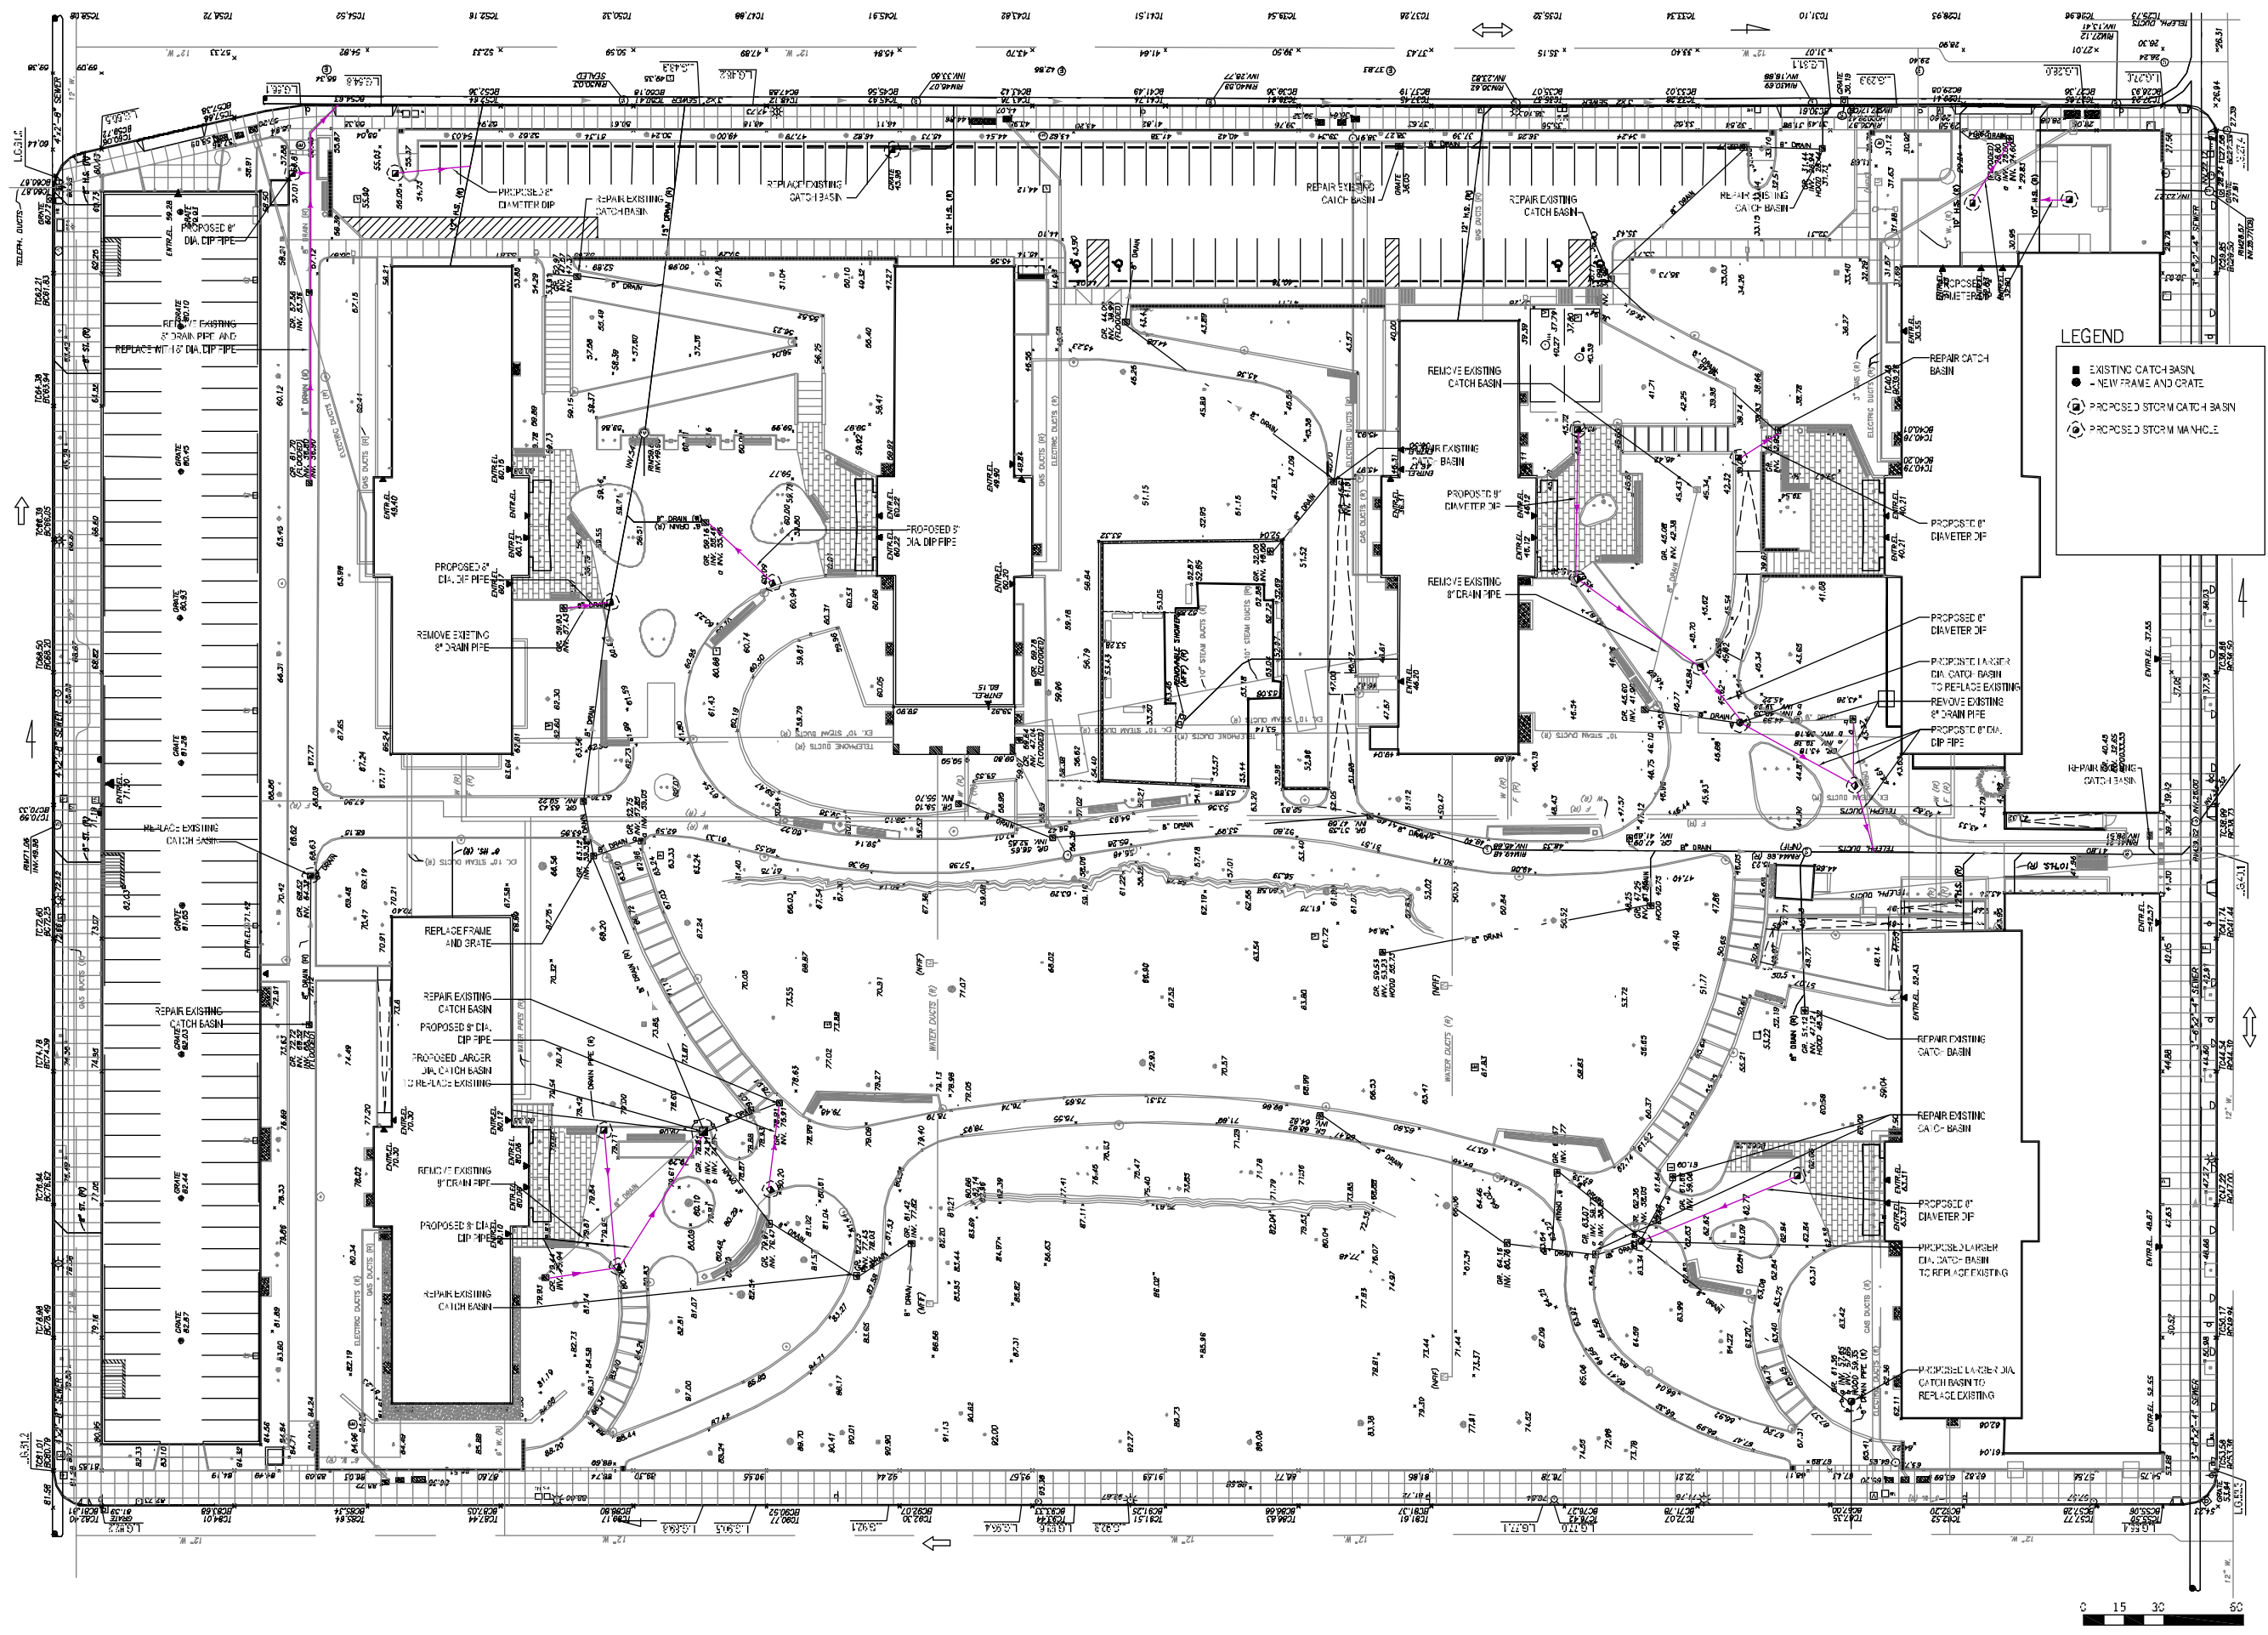

LEGEND

 - EXISTING CATCH BASIN
- - NEW FRAME AND GRATE
- PROPOSED STORM CATCH BASIN
- PROPOSED STORM MANHOLE



SARATOGA ASSOCIATES
 Landscapes Architects, Architects,
 Engineers, and Planners, P.C.
 100 WEST E. 125TH STREET
 SUITE 200
 HARTFORD, CT 06105
 TEL: 860.234.1111
 FAX: 860.234.1112
 WWW.SARATOGAASSOCIATES.COM

emphasis design inc.
 95 WALL STREET, SUITE 200, NEW YORK, NY 10005
 TEL: 212.677.1111
 FAX: 212.677.1112
 WWW.EMPHASISDESIGN.COM


Michael Gokin
 President & Managing Director
 112 E. 42ND STREET, SUITE 200
 NEW YORK, NY 10017
 TEL: 212.697.1111
 FAX: 212.697.1112
 WWW.MICHAELGOKIN.COM

NORTHERN DESIGNS
 Irrigation Consultants & Designers
 100 WEST 125TH STREET, SUITE 200
 HARTFORD, CT 06105
 TEL: 860.234.1111
 FAX: 860.234.1112
 WWW.NORTHERNDESIGNS.COM

MORNINGSIDE GARDENS
 SCHEMATIC DESIGN
 100 WEST 125TH STREET, SUITE 200
 HARTFORD, CT 06105
 TEL: 860.234.1111
 FAX: 860.234.1112
 WWW.MORNINGSIDEGARDENS.COM

DATE: 09/24/2014
DRAWN BY: J.S.P.
CHECKED BY: J.S.P.
REVISIONS:
 1. 09/24/2014
 2. 10/01/2014
 3. 10/01/2014
 4. 10/01/2014
 100. 10/01/2014

DRAINAGE PLAN

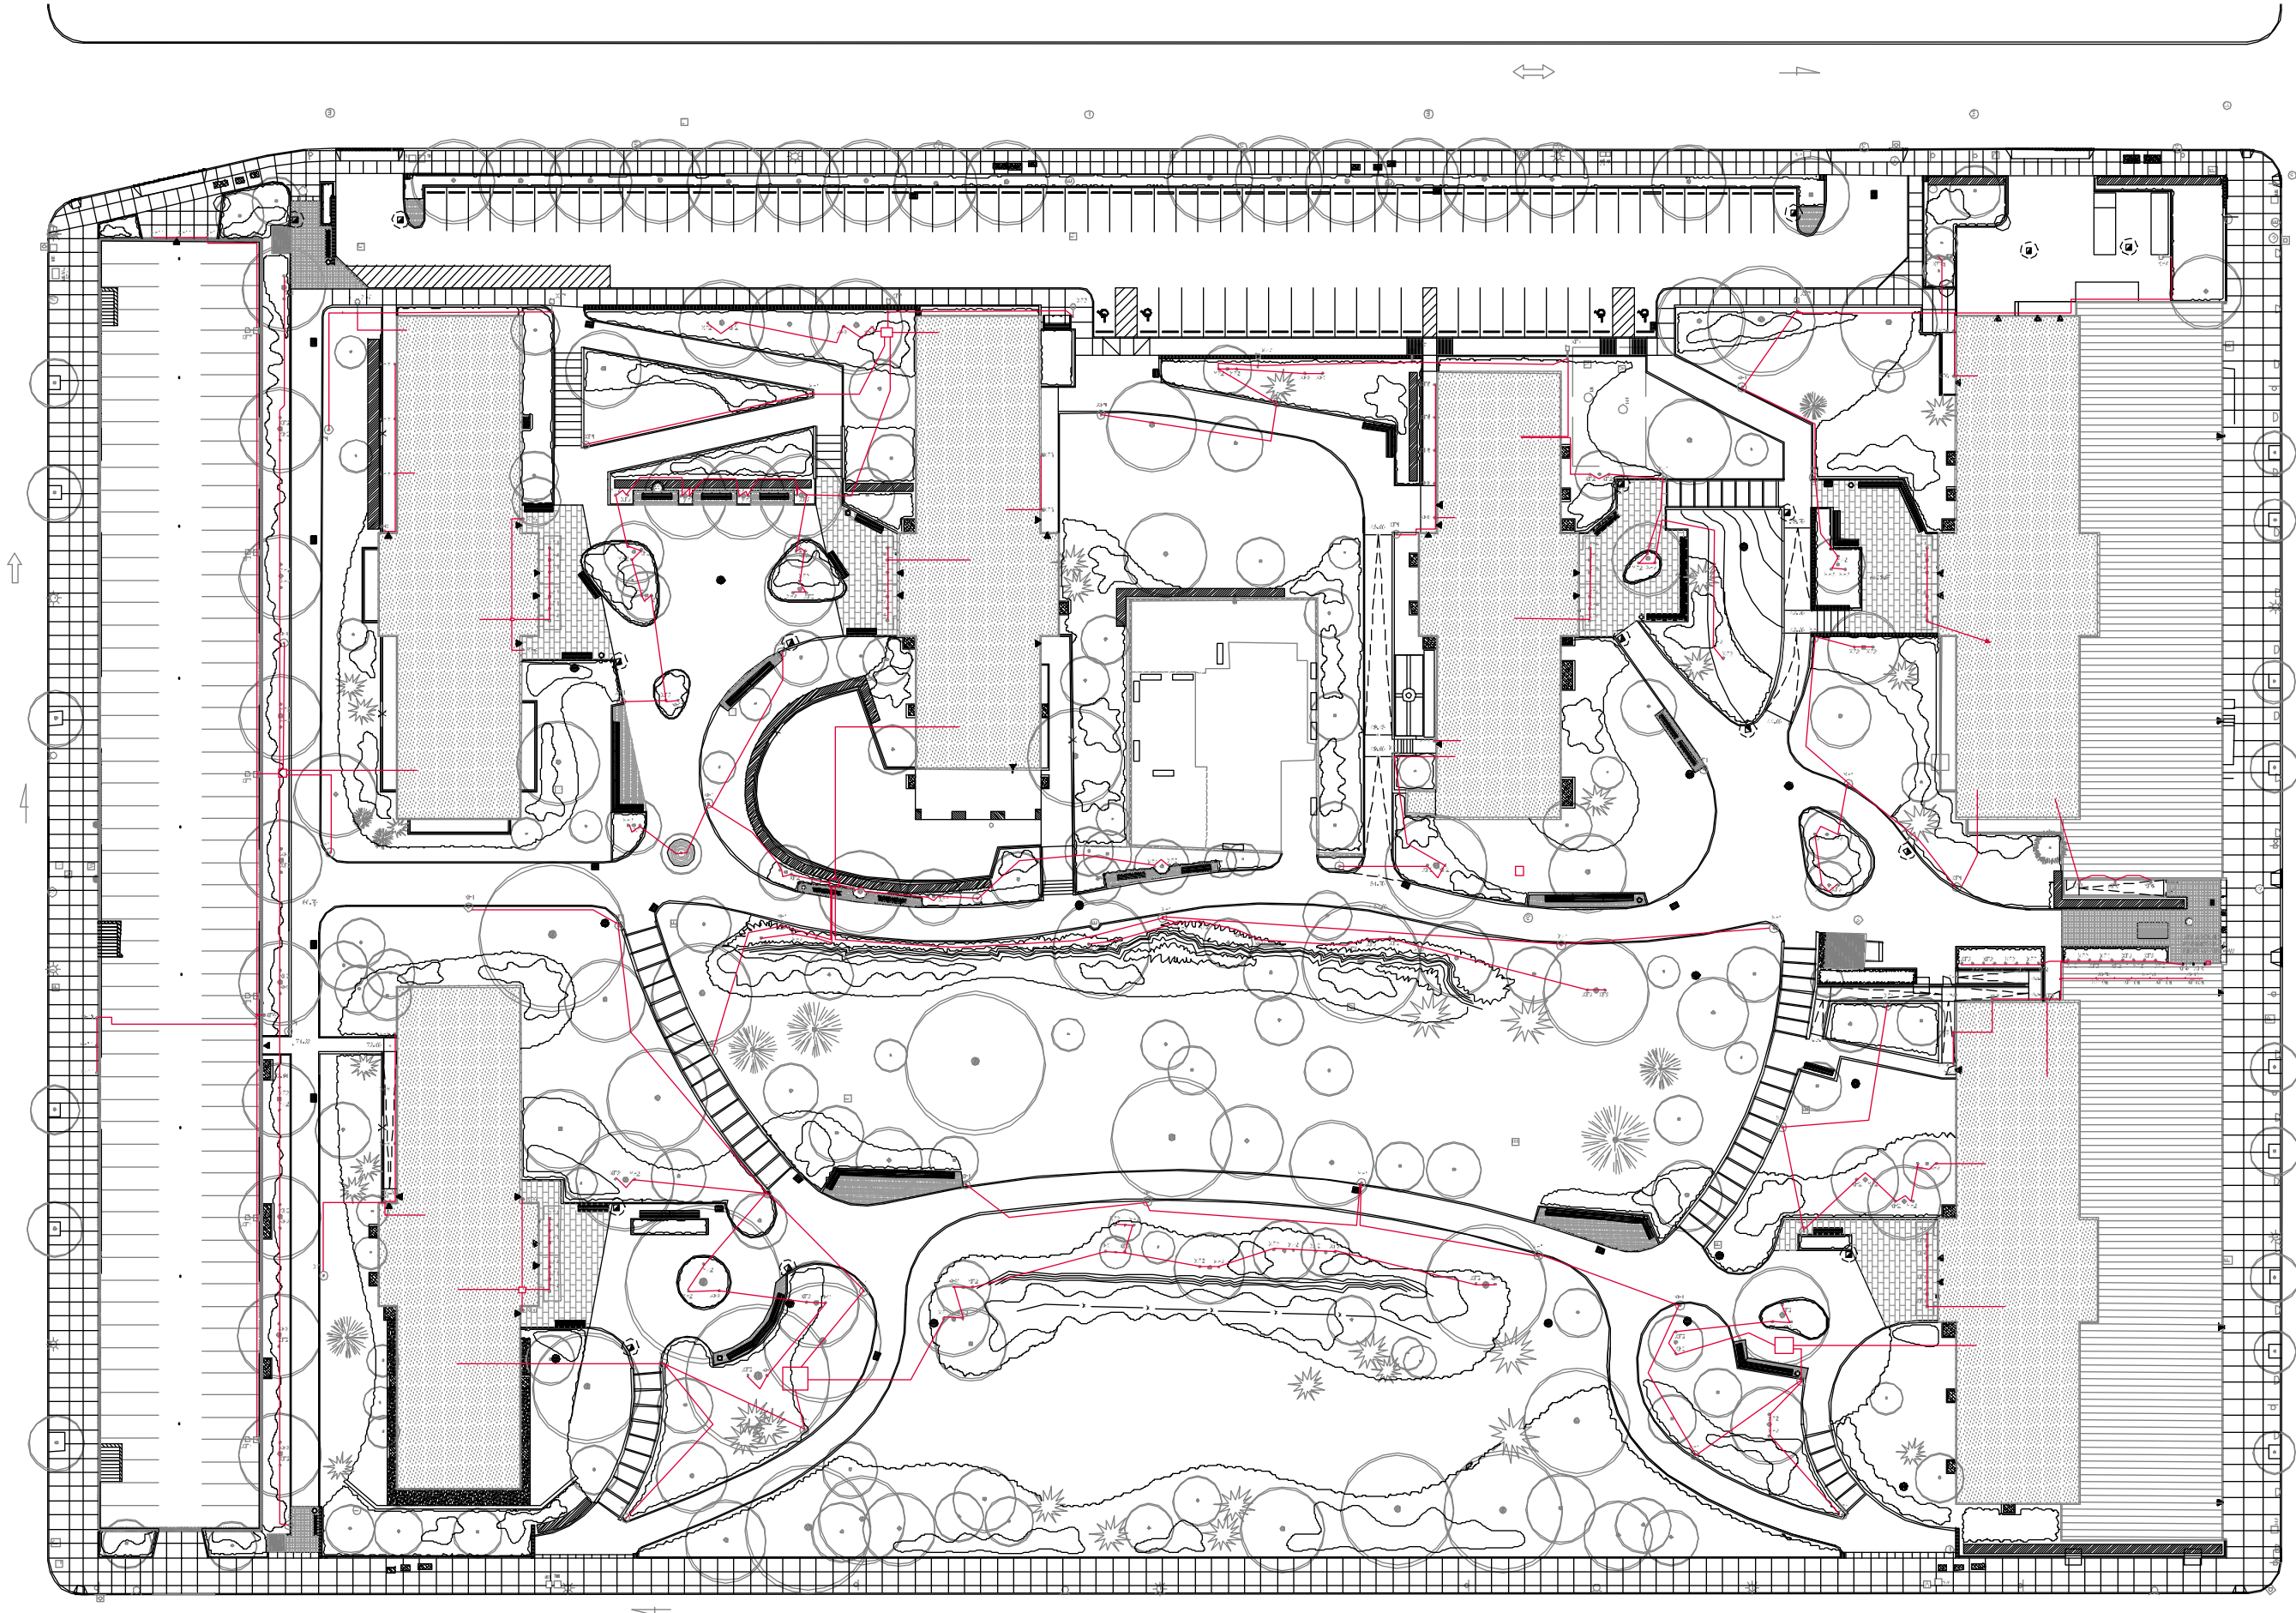

SCALE: 1"=30' @ 22"x34"
SCALE: 1"=60' @ 11"x17"

SARATOGA ASSOCIATES
Landscape Architects, Architects,
Engineers, and Planners, P.C.
100 VERNON AVENUE, SUITE 200
SARATOGA, NY 12158

emphasis design inc.
35 WINDSOR PARK, SUITE 101, LENOX, NY 12546
TEL: 518-752-1111

Michael Golkin
Principal & Project Director
122 S. A-20N CT. 444-244-6266

WEDLINGER ASSOCIATES INC.
375 Hudson Street, NY 10014



MORNINGSIDE GARDENS
SCHEMATIC DESIGN
400 HUNTER STREET, SUITE 200, ALBANY, NY 12202
L. CARROLL, P. CARROLL, H. CARROLL
SARATOGA ASSOCIATES INC.

DATE: 03/20/14
DRAWN BY: J. B. W.
CHECKED BY: J. B. W.
REVISIONS:
NO. 1: 03/20/14

Electrical Plan